


1 DEPT. MANAGER POWER PLAN  
SCALE : 1/2" = 1'-0"


### ELECTRICAL WIRING KEY NOTES (X)

1. VERIFY EXISTING CONDITIONS.
2. RECEPTACLE TO BE FED FROM CLEAN POWER CIRCUIT. RE-FEED CIRCUIT AS NECESSARY TO MEET CONSTRUCTION REQUIREMENTS. REPLACE STANDARD COLOR RECEPTACLE WITH ORANGE RECEPTACLE.
3. EXISTING "DIRTY POWER" RECEPTACLE.
4. EXISTING RECEPTACLE TO BE FED (RE-FED) FROM "DIRTY" POWER CIRCUIT. RE-FEED CIRCUIT AS NECESSARY TO MEET CONSTRUCTION REQUIREMENTS. REPLACE ORANGE RECEPTACLE WITH STANDARD COLOR RECEPTACLE.
5. EXISTING DATA PORTS TO BE REMOVED AND REPLACED WITH NEW CONNECTION RECESSED IN WALL.

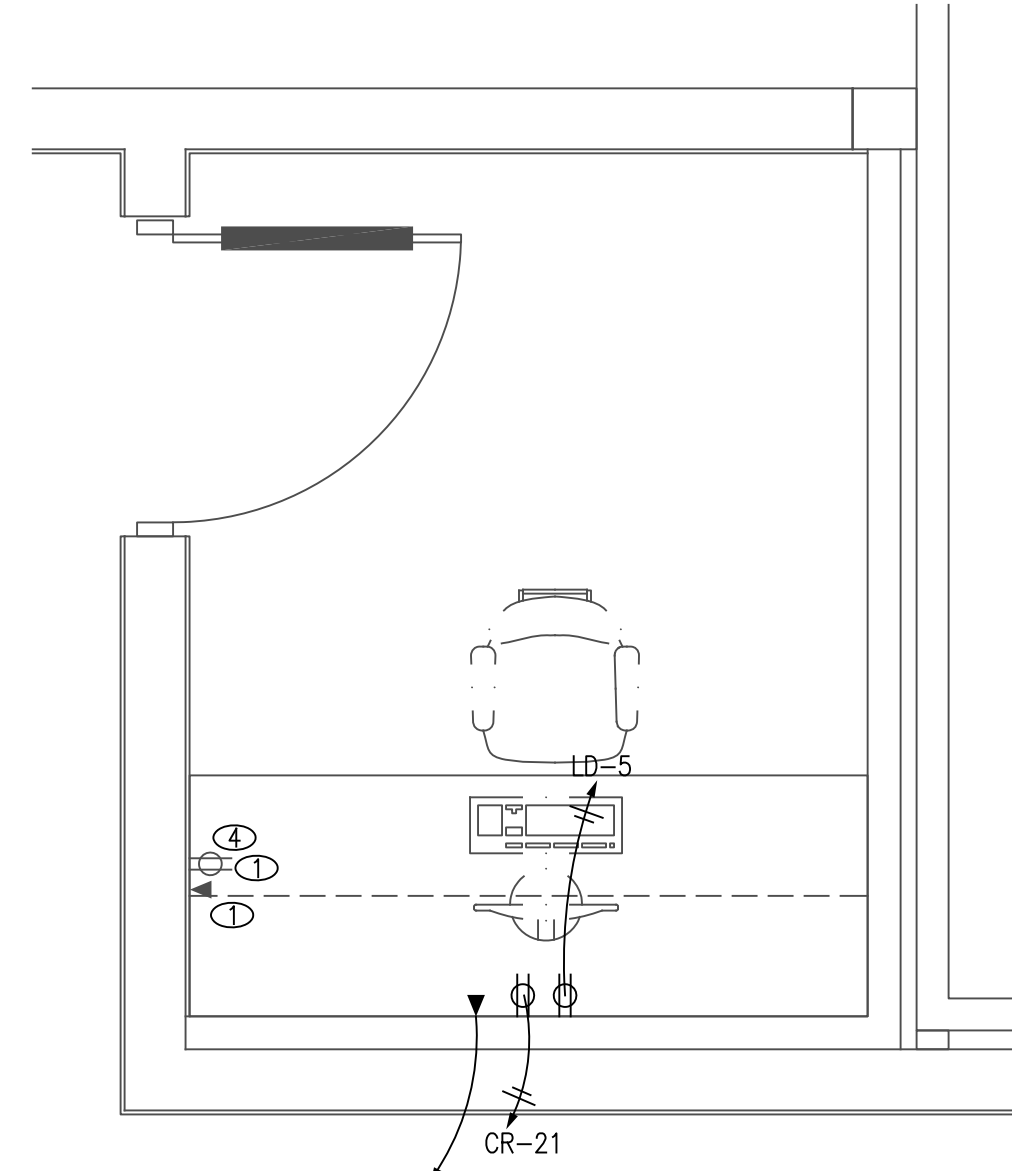


EXISTING INFRASTRUCTURE TO REMAIN. IF NEW,  
PROVIDE 3/4" CONDUIT WITH (1) CAT-5e  
UNSHIELDED ETHERNET CABLE FROM PC  
COMMUNICATIONS J-BOX TO PC TRAINING ROOM  
FOR WORKSTATION

3 ENLARGED ASSOCIATES TRAINING POWER PLAN  
SCALE : 1/2" = 1'-0"

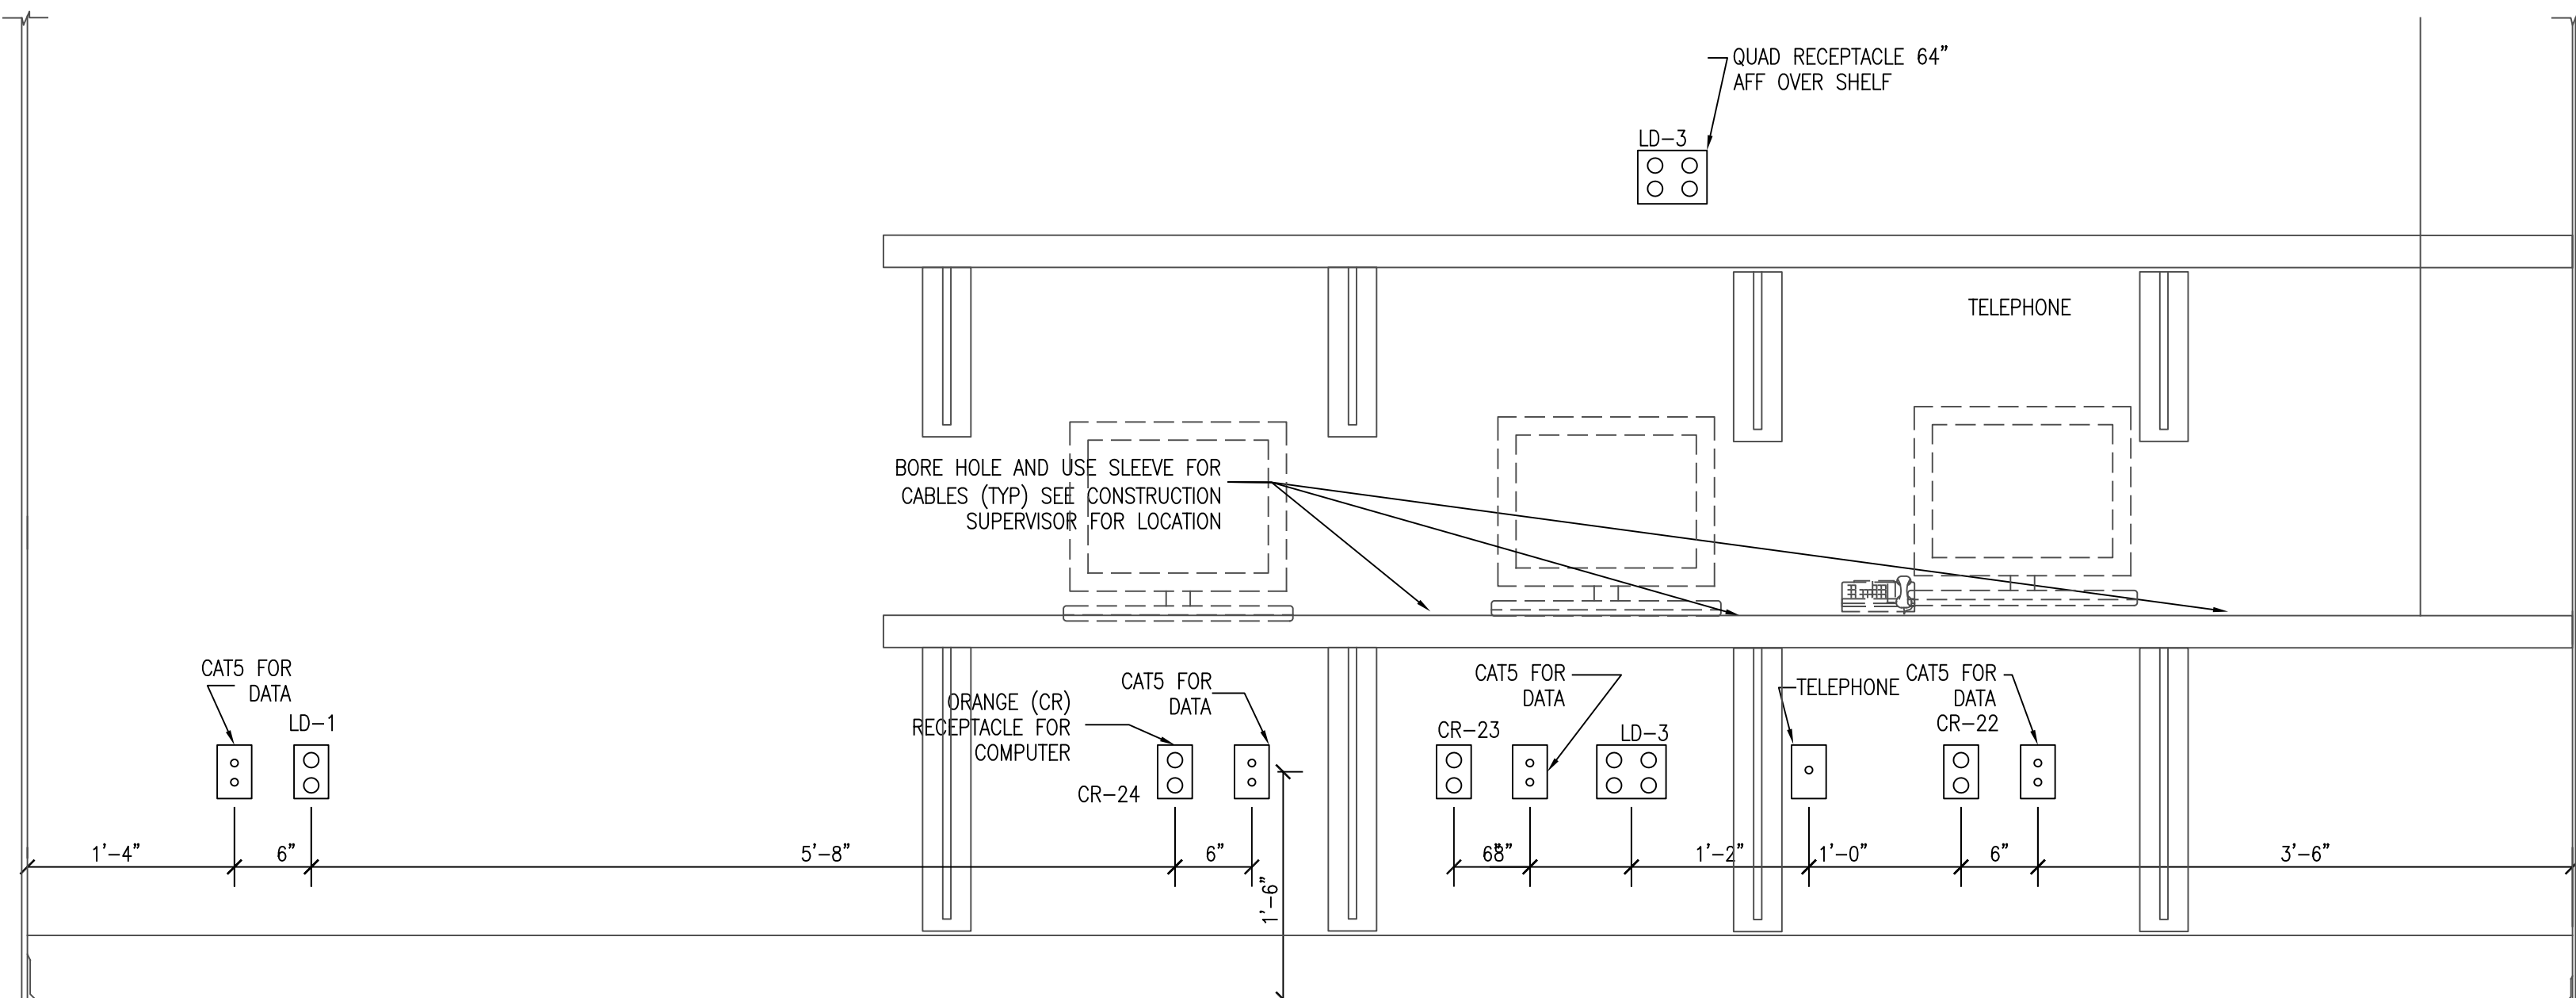

2 DEPARTMENT MANAGERS COUNTER ELEVATION  
SCALE : NONE

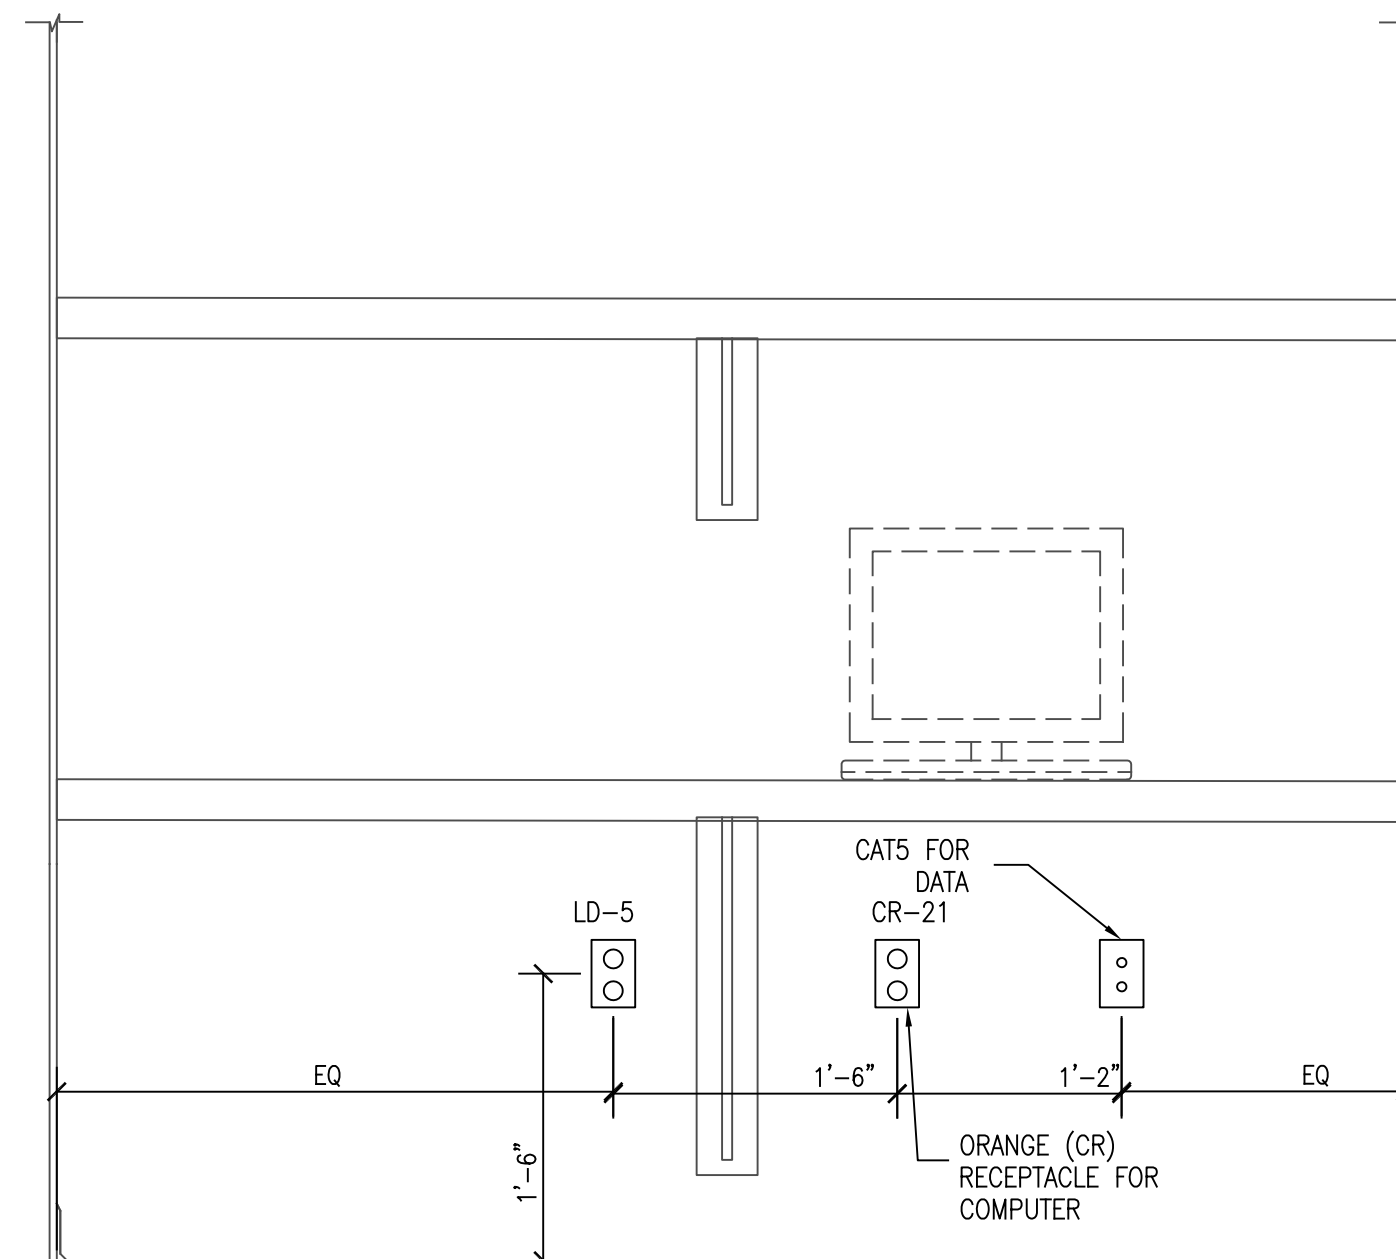

4 ASSOCIATES TRAINING COUNTER ELEVATION  
SCALE : NONE