


ARCHITECT'S SEAL:

PROFESSIONAL CERTIFICATION I
HEREBY CERTIFY THAT THESE
DOCUMENTS WERE PREPARED OR
APPROVED BY ME AND THAT I AM A
DULY LICENSED ENGINEER UNDER
THE LAWS OF THE STATE OF
MARYLAND.
LICENSE NO. 05-51160
EXPIRATION DATE: 02/1/2021

ENGINEER'S SEAL:

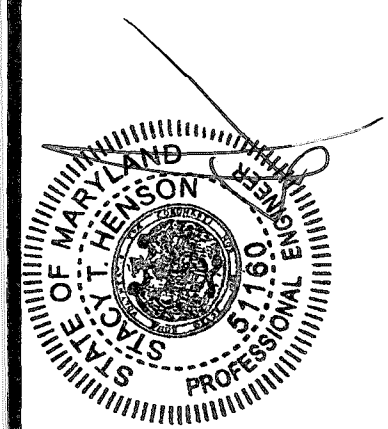

JAN 30 2020

REVISIONS

NO. DATE REMARKS

FOOD LION

2118 Executive Drive, Salisbury, NC 28145
Telephone: 781.533.0259
foodlion.com
Food Lion is a DELAWARE AMERICA company.FOOD LION
REMODEL
STORE #1662
410 SANDY SPRING RD
LAUREL, MD 20707

PROJECT NO: 2019.0893

DATE: 1-30-20


19 OF 24

E4.03

CUST. SERV. WORKRM &
CHECK OUT COMM. PLAN


CHECKED: BKJ DRAWN: MW

CORBIR - 01/29/2020 4:47:52 AM

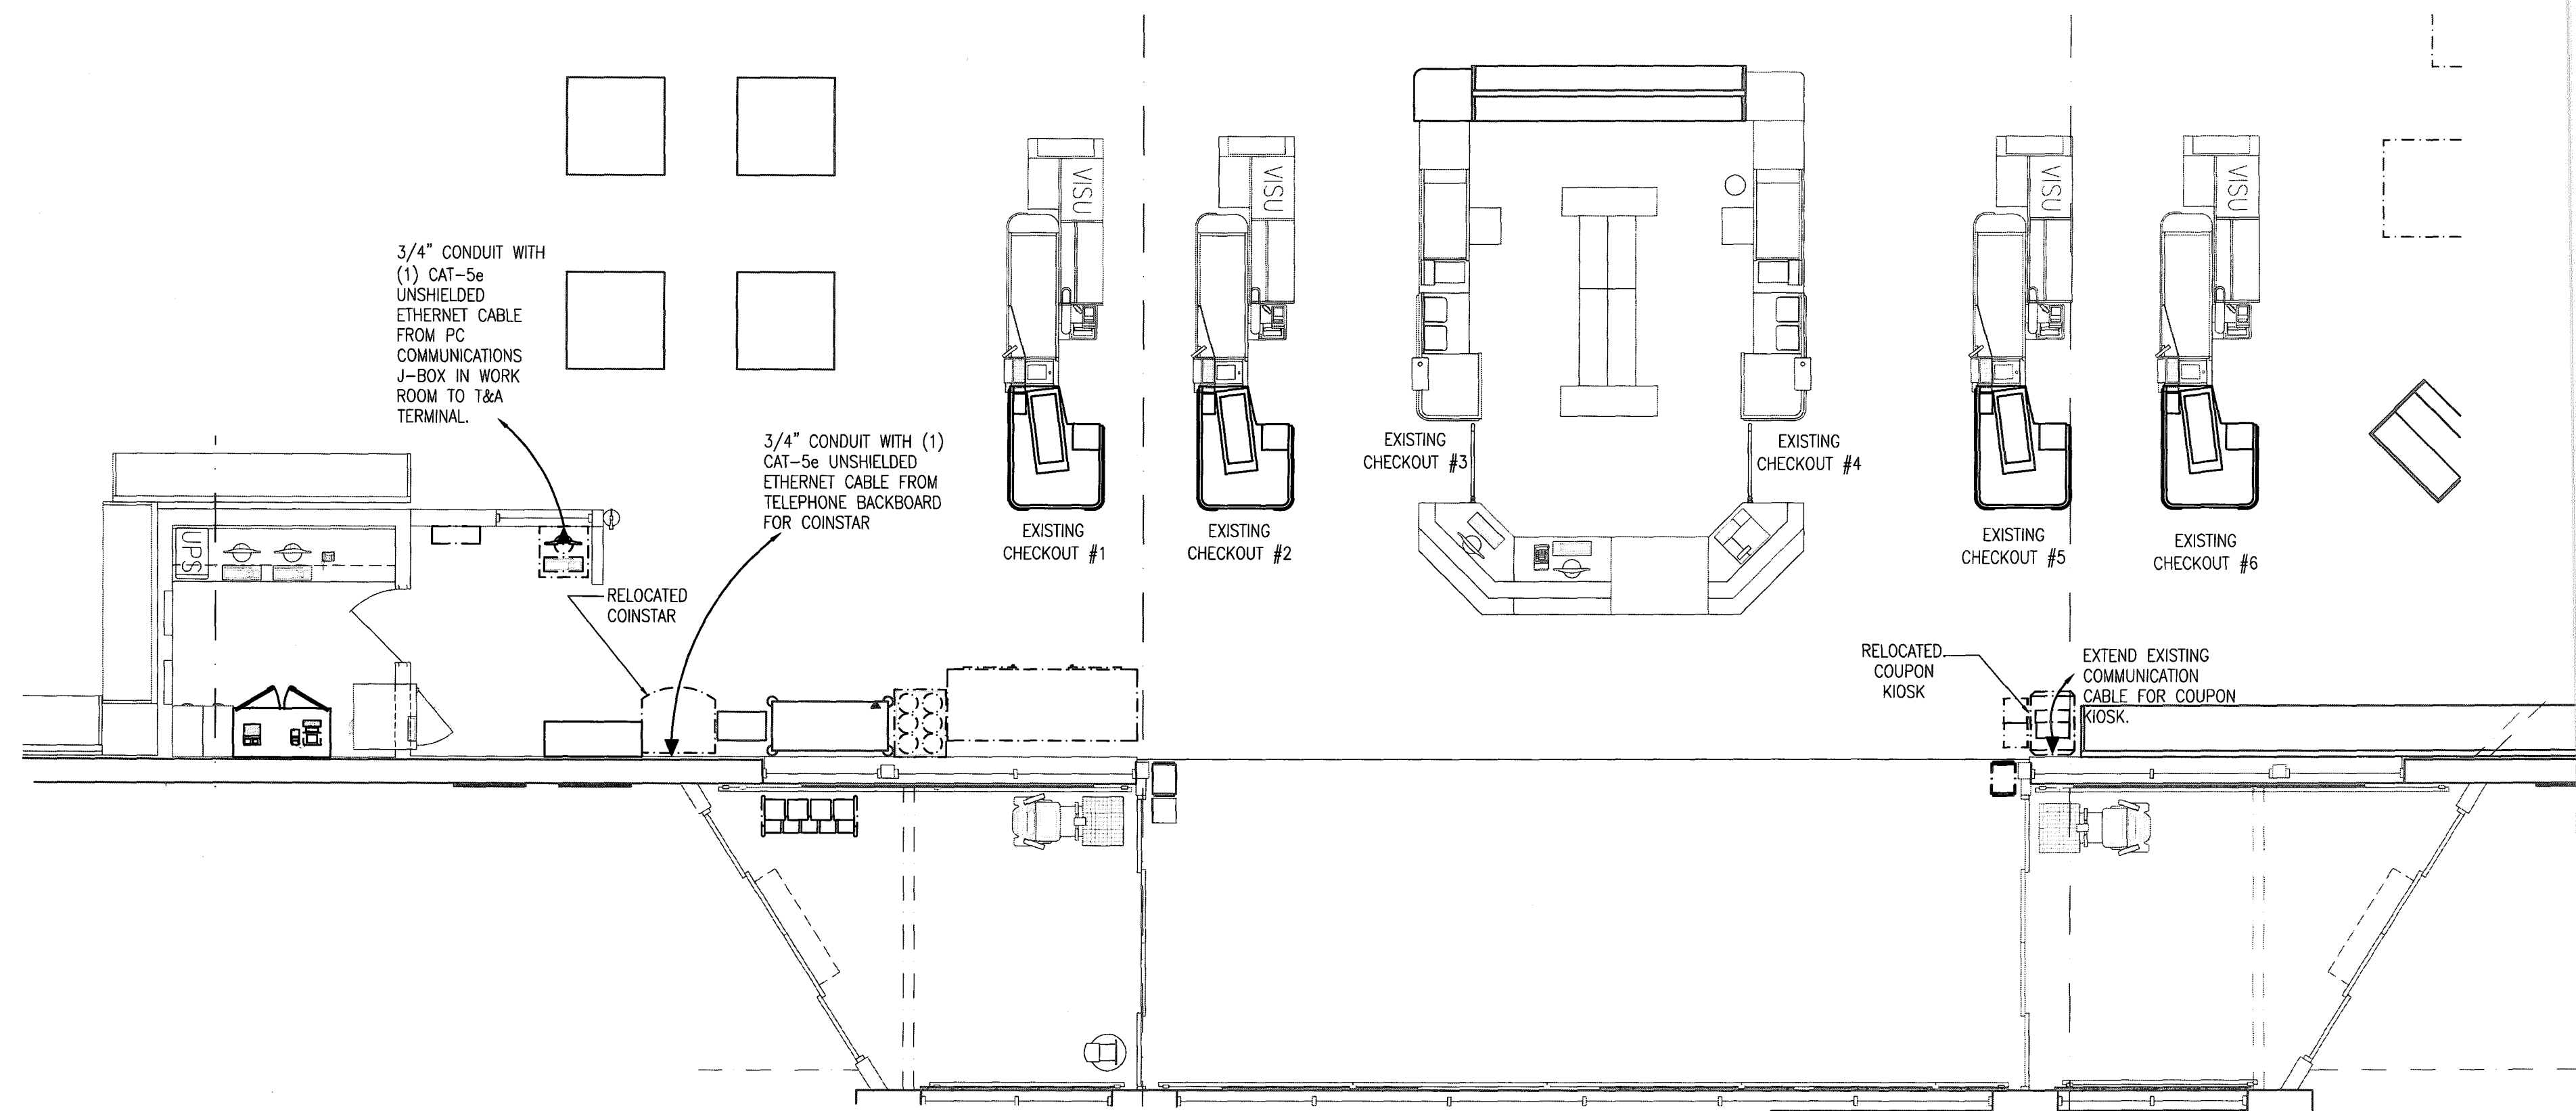


1 ENLARGED COMMUNICATION WIRING PLAN

E4.03 SCALE: 3/16" = 1'-0"

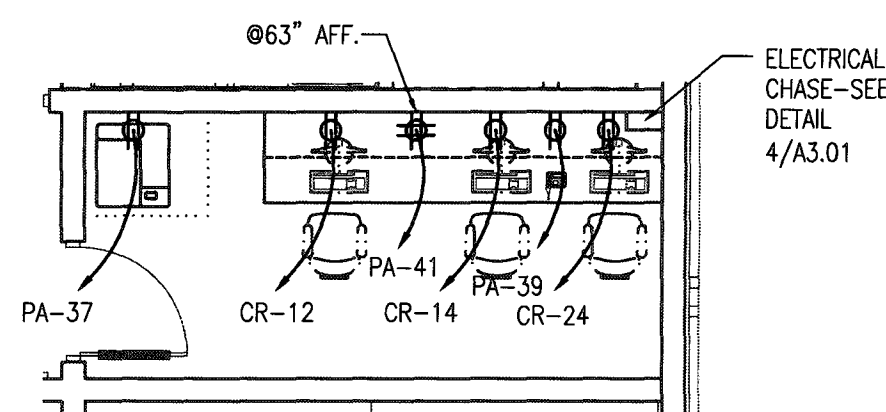

2 ENLARGED DEPT. MANAGER'S OFFICE POWER PLAN

E4.03 SCALE: 3/16" = 1'-0"

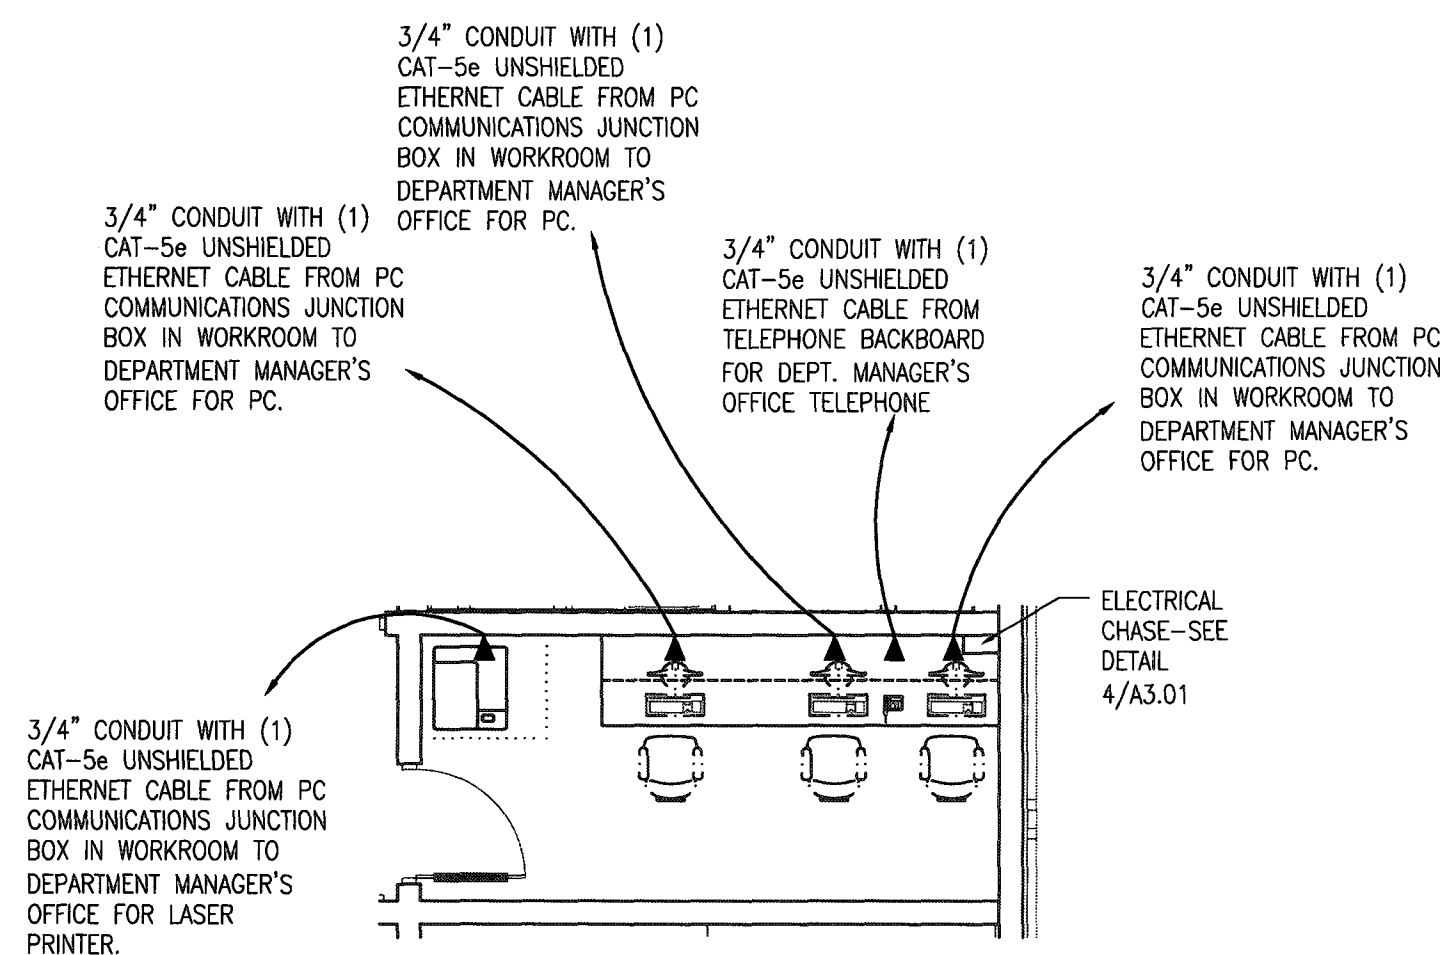

3 ENLARGED DEPT. MANAGER'S OFFICE COMMUNICATION WIRING PLAN

E4.03 SCALE: 3/16" = 1'-0"

