



**2** CUSTOMER SERVICE KIOSK COMMUNICATIONS PLAN  
E4.03 SCALE : 1/2" = 1'-0"


- CHECKOUT INSTALLATION NOTES**
1. SEE SHEET E4.02 FOR WORKROOM AND CUSTOMER SERVICE REGISTER AND CHECKOUTS ELECTRICAL WIRING.
  2. ALL FITTINGS SHALL MEET ALL N.E.C. REQUIREMENTS AND SHALL BE U.L. LISTED.
  3. CHECKOUT COMMUNICATIONS CABLING & TERMINATIONS SHALL BE BY OTHERS.
  4. SEE CAT 5 RISER NOTES ON SHEET E2.01.

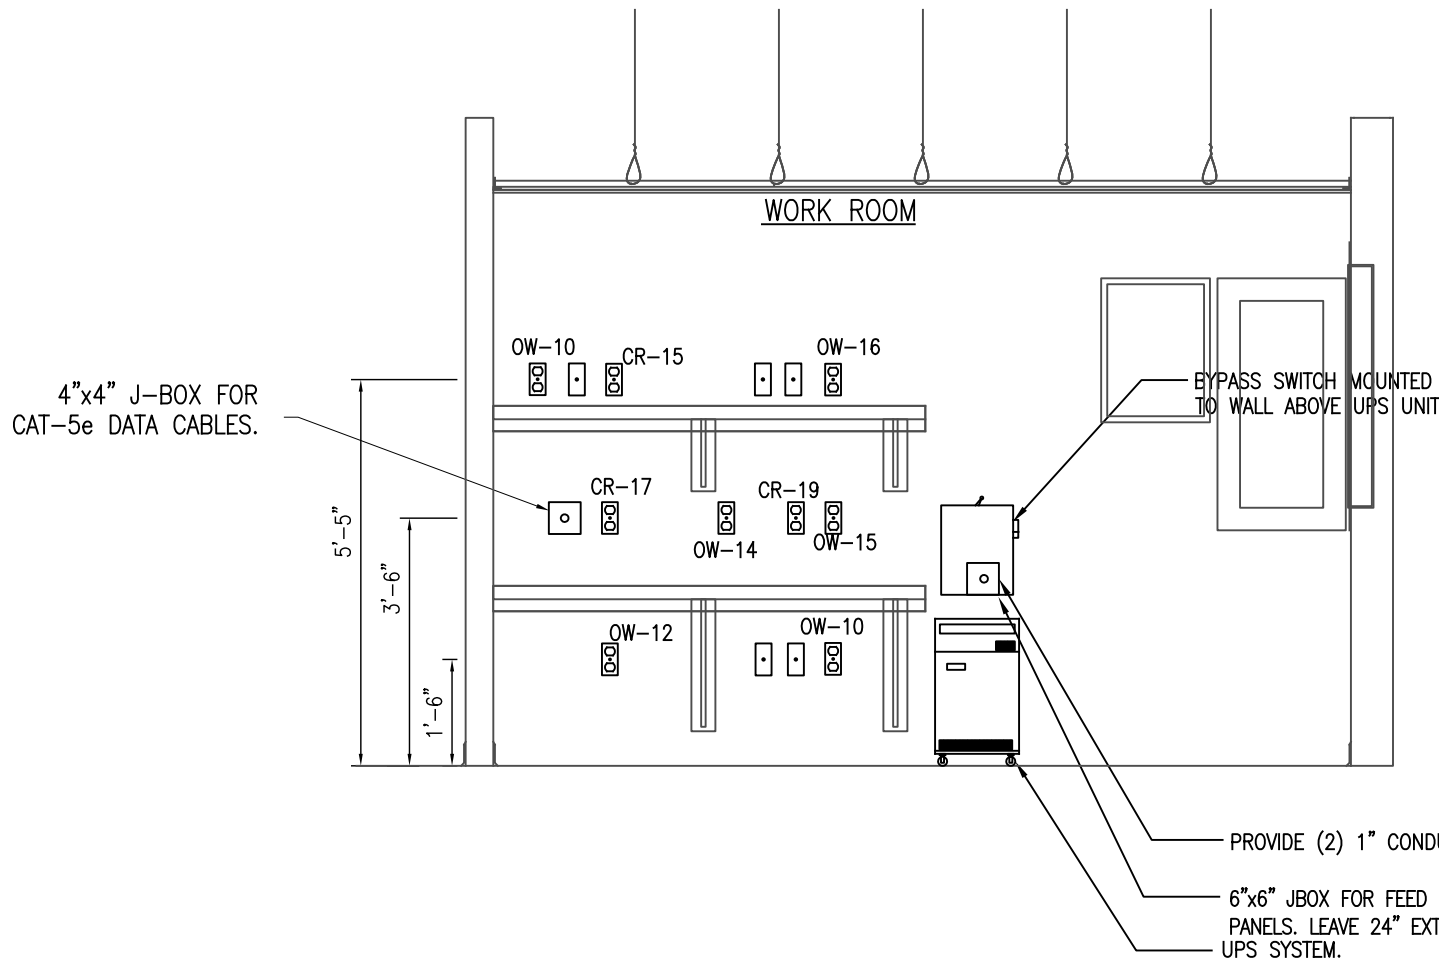



**3** WORK ROOM ELEVATION  
E4.03 SCALE : NOT TO SCALE

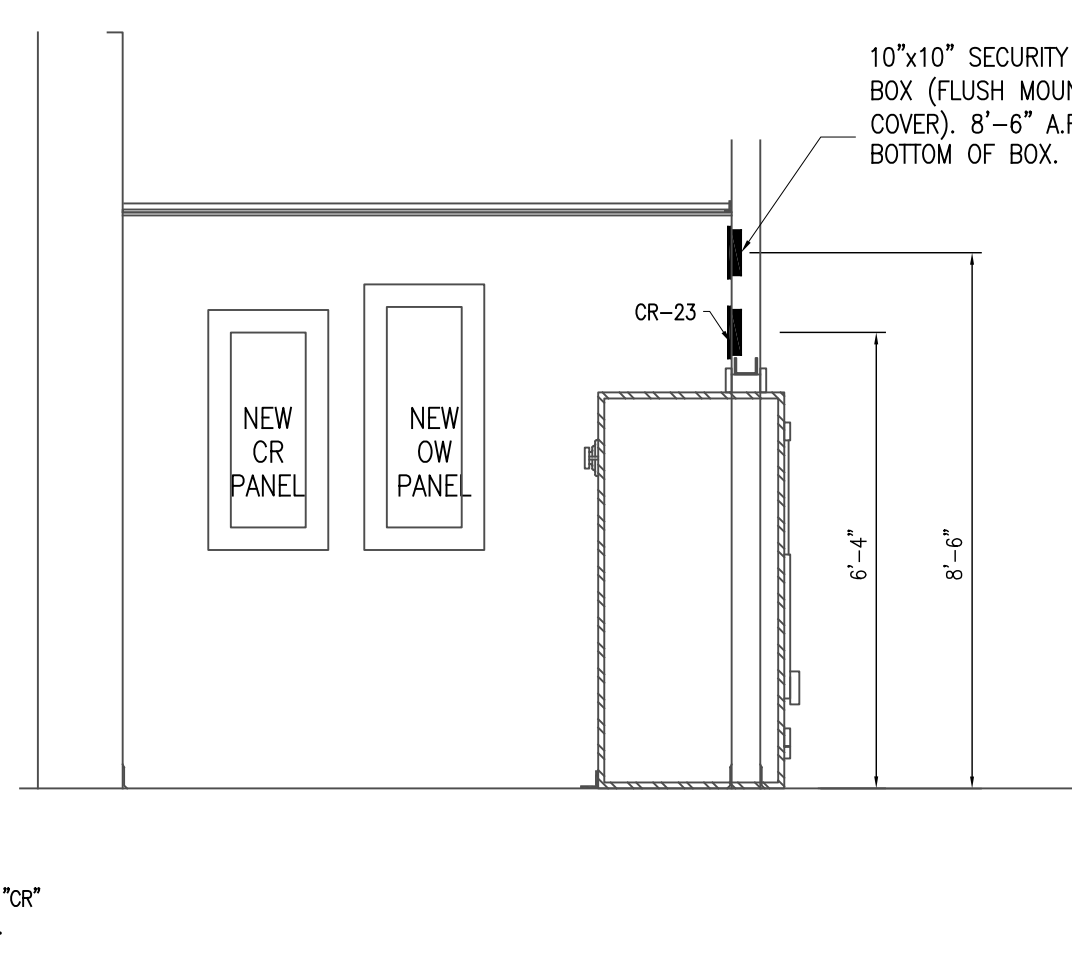


**4** WORK ROOM ELEVATION  
E4.03 SCALE : NOT TO SCALE

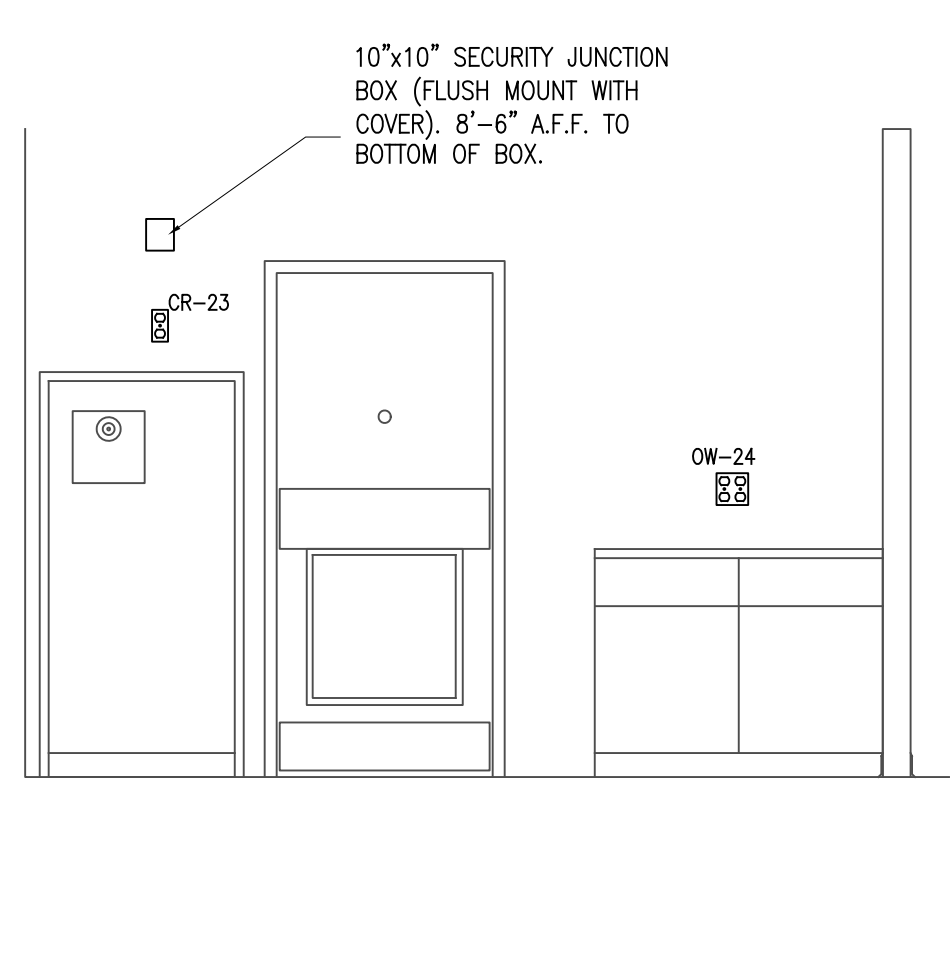

**5** WORK ROOM ELEVATION  
E4.03 SCALE : NOT TO SCALE

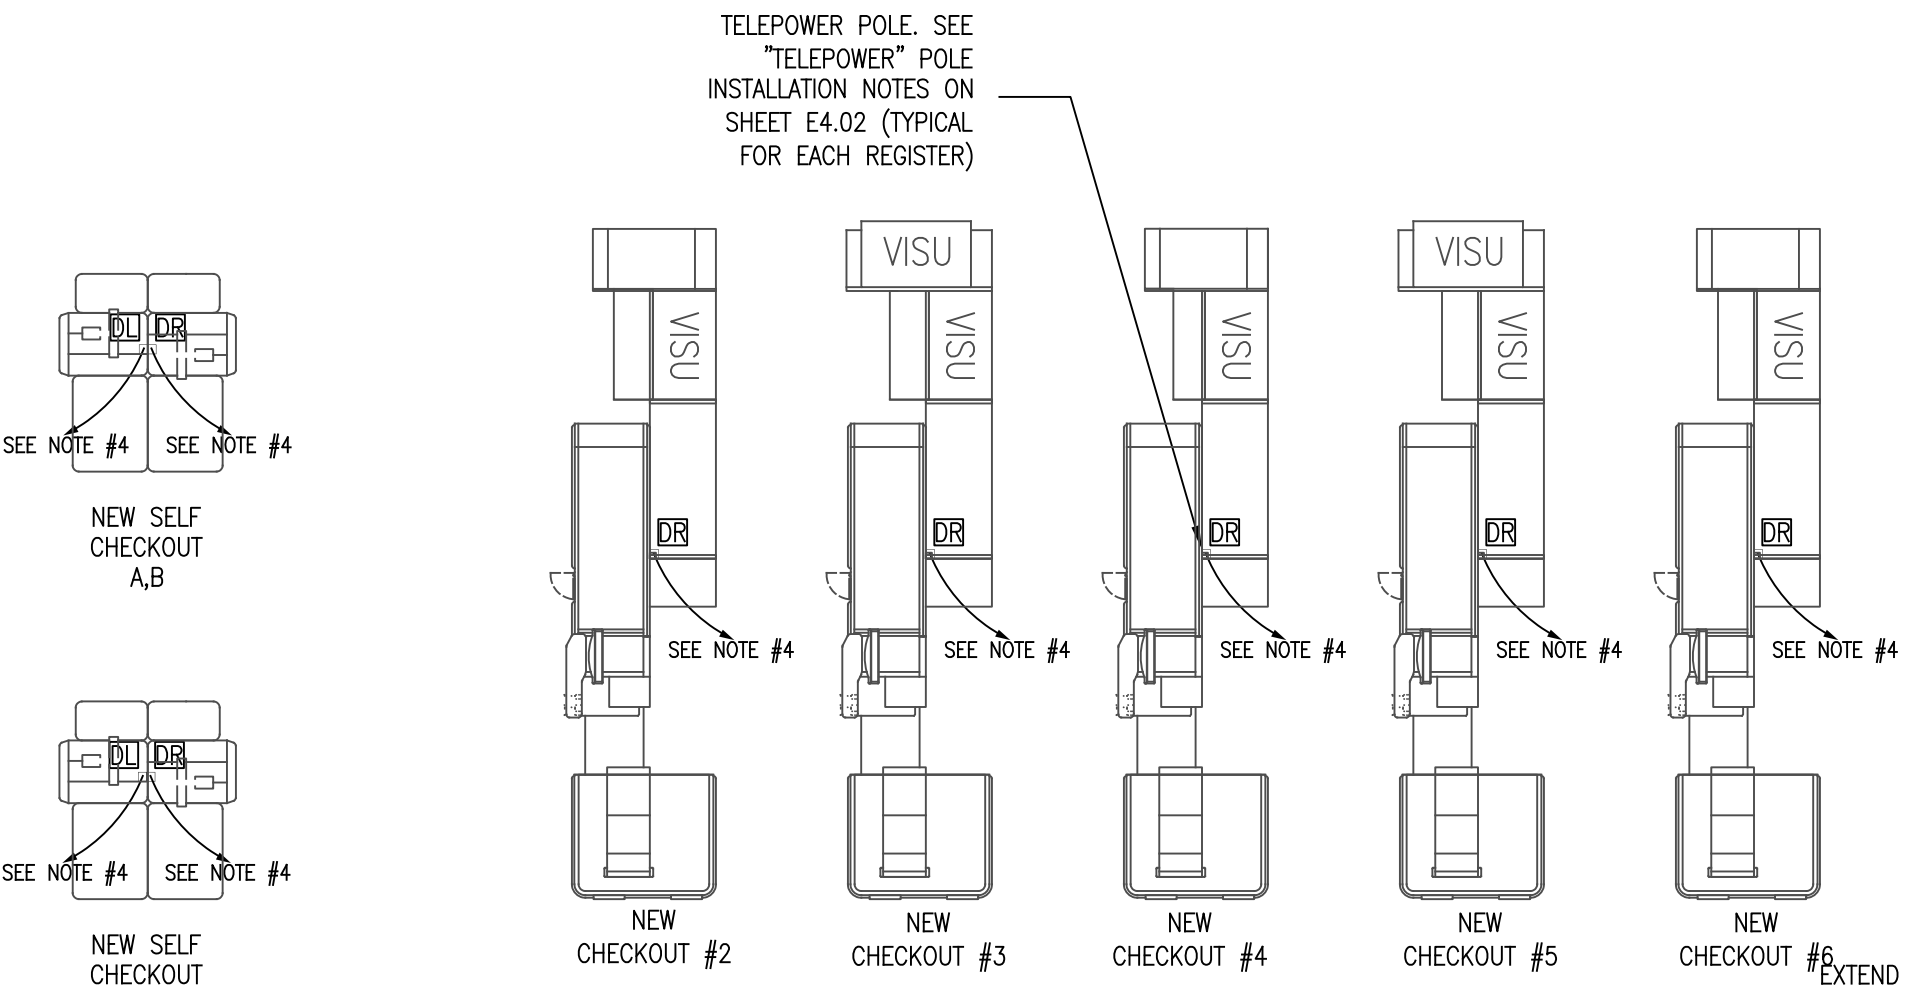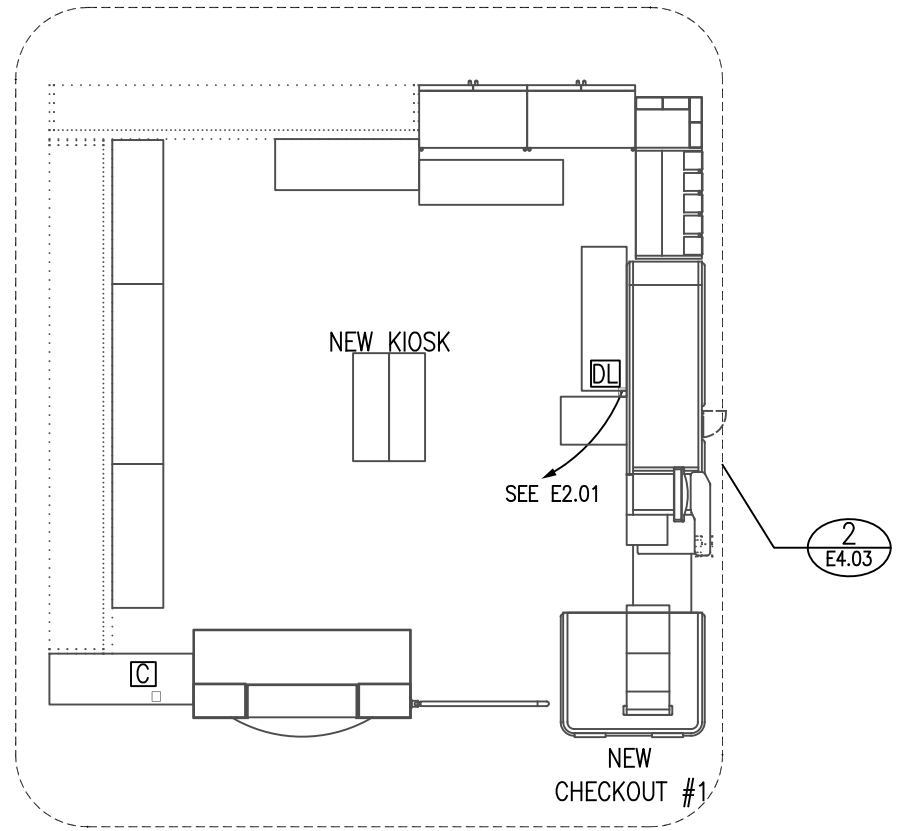

- NOTES:**
- ALL CAT 5 CABLE SHALL BE BELDEN 1212 CMR CAT-5E 4 PAIR 24 AWG(BELDEN 1200 DATATWST CABLE SERIES)
  - ALL CAT 5 CABLE TO BE INSTALLED IN 3/4" CONDUIT UNLESS NOTED OTHERWISE

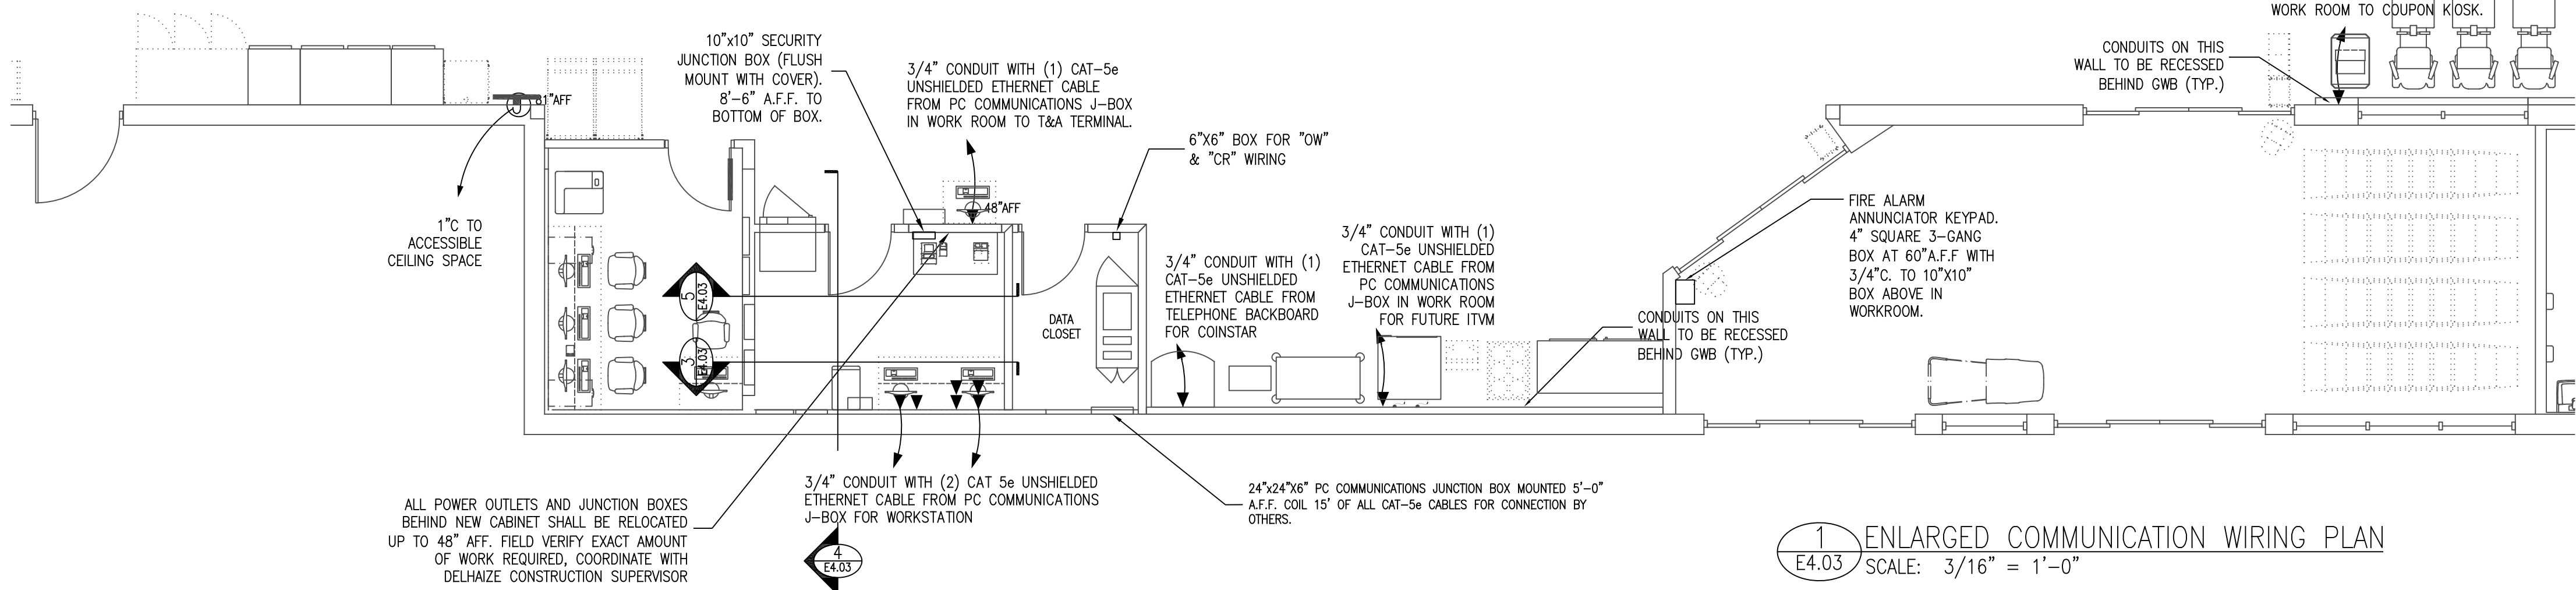

**1** ENLARGED COMMUNICATION WIRING PLAN  
E4.03 SCALE: 3/16" = 1'-0"