

REVISIONS		
NO.	DESCRIPTION	DATE




**FOOD LION 2560**  
7514 North Point Rd  
Sparrows Point, MD 21219

**CUSTOMER SERVICE, WORKROOM, AND  
CHECKOUT COMMUNICATION PLAN**

DRAWING FILE NAME  
**2560 E4.03\_00**  
RFS JOB #  
**2019-042**  
DATE  
**02/21/2020**  
**E4.03**  
8 OF 14


**STURGILL  
ENGINEERING  
P.A.**  
ONE SOUTH MAIN ST.  
LEXINGTON, NC 27292  
(336) 288-1249 P.H.  
(336) 236-6393 FAX

C-3617

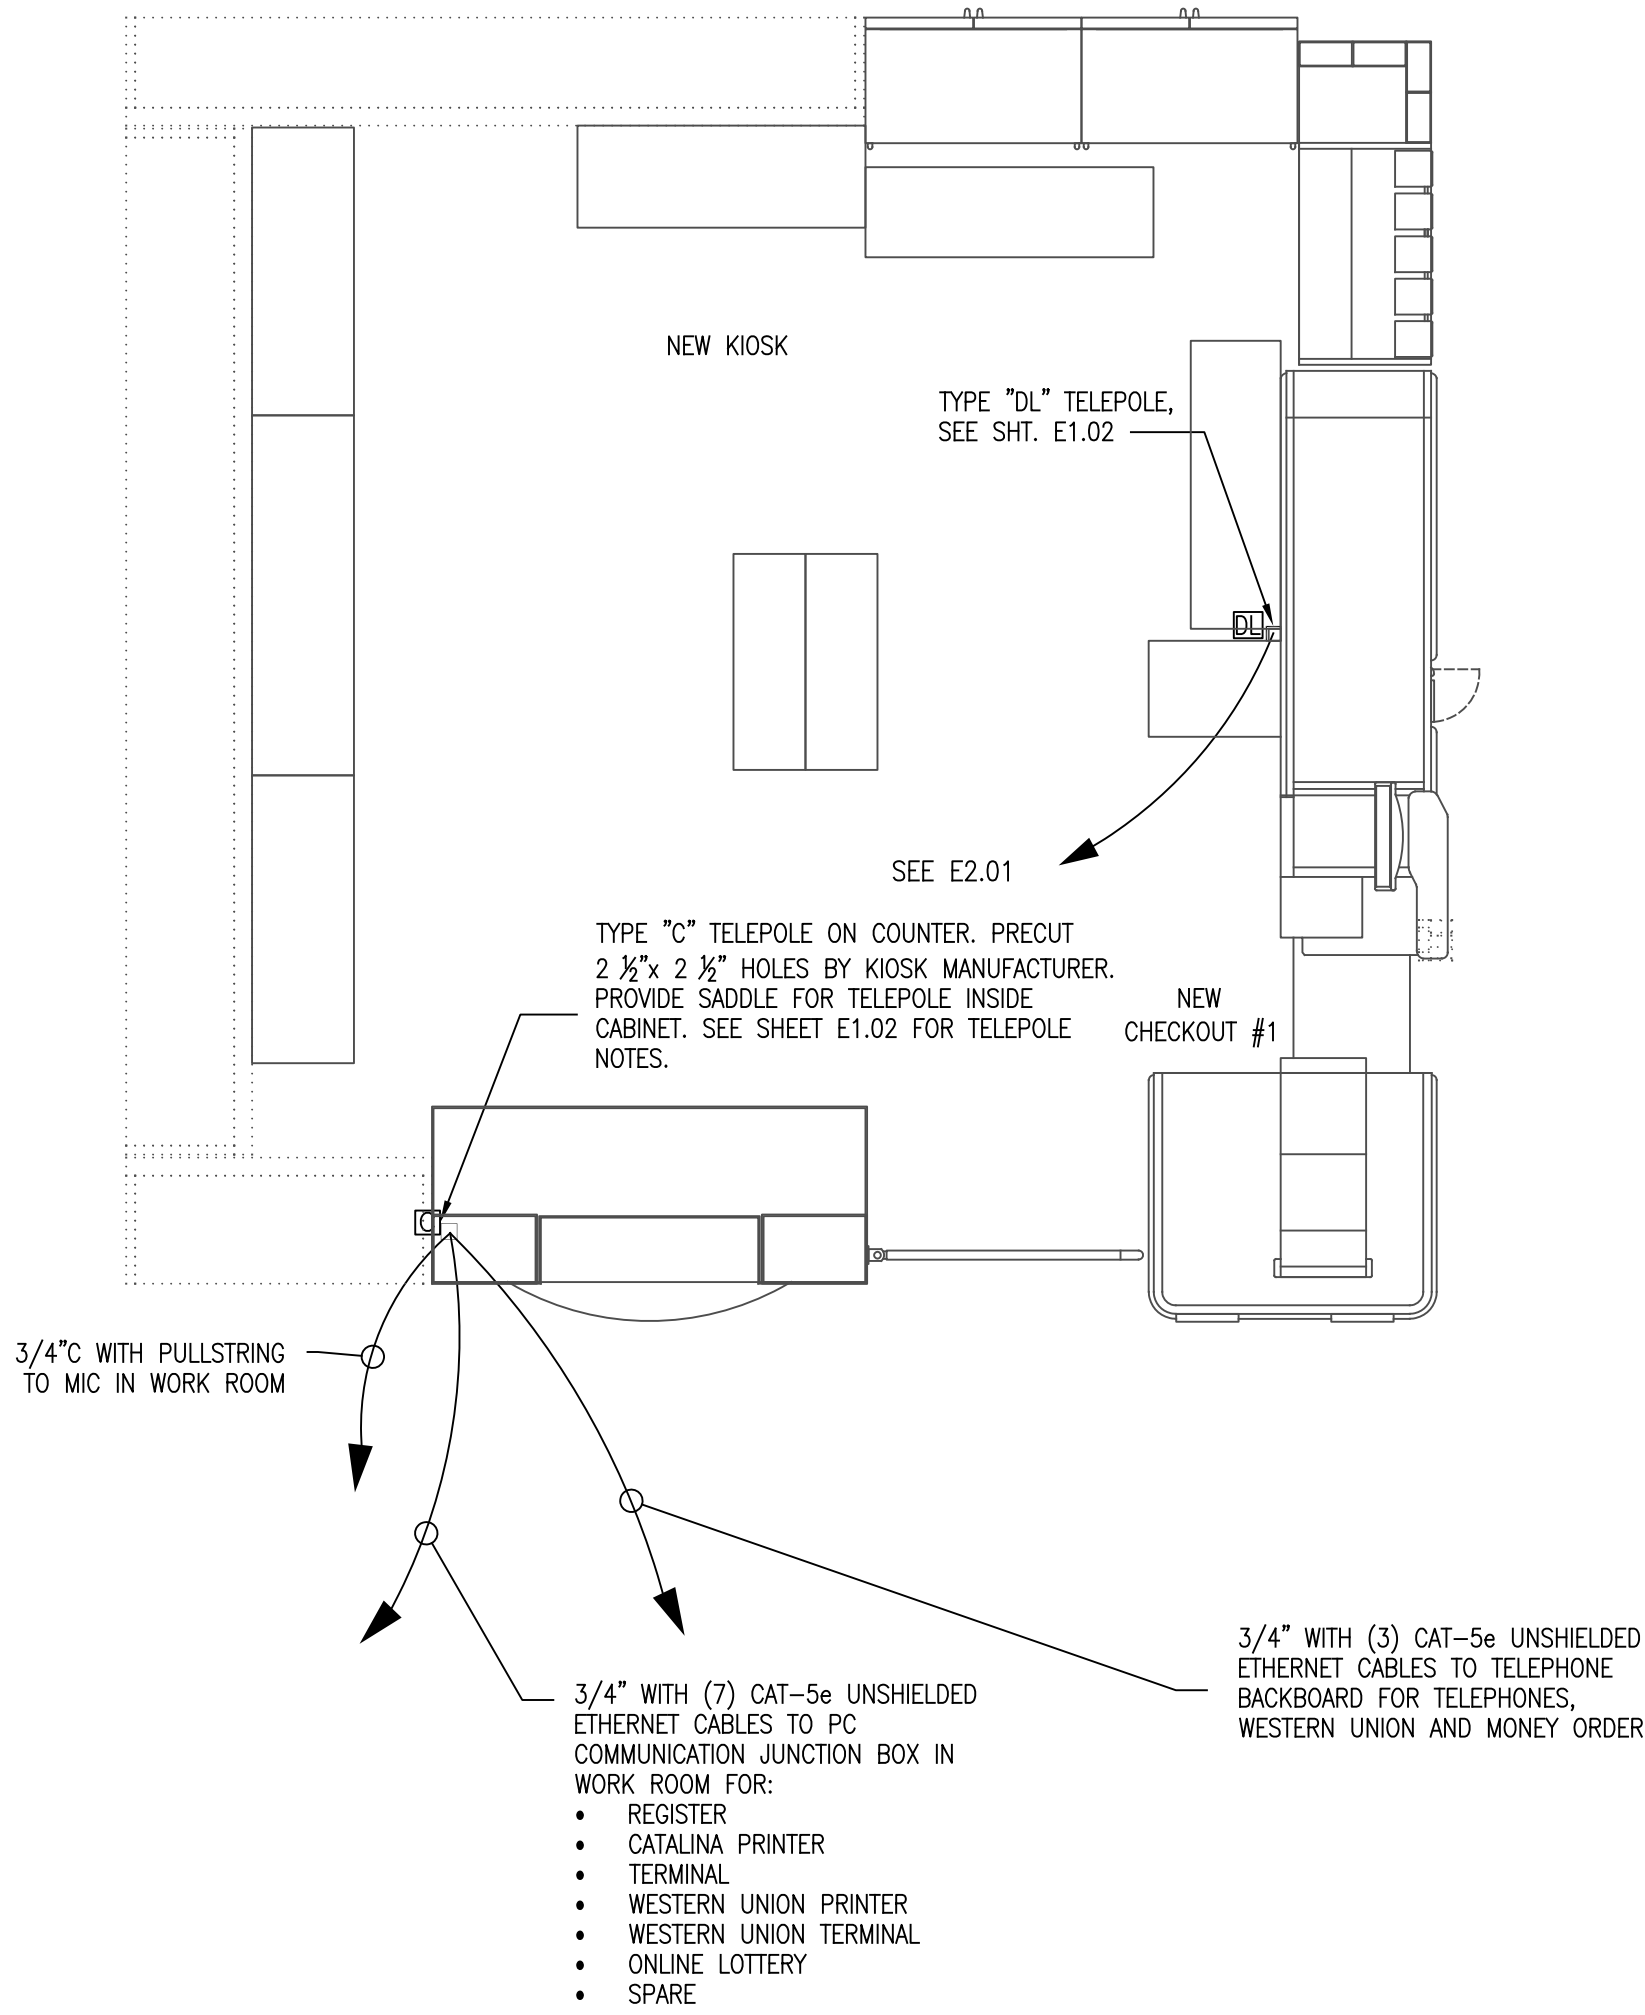

**2 CUSTOMER SERVICE KIOSK COMMUNICATIONS PLAN**  
E4.03 SCALE : 1/2" = 1'-0"

- NOTES:
- ALL CAT 5 CABLE SHALL BE BELDEN 1212 CMR CAT-5E 4 PAIR 24 AWG(BELDEN 1200 DATATWIST CABLE SERIES)
  - ALL CAT 5 CABLE TO BE INSTALLED IN 3/4" CONDUIT UNLESS NOTED OTHERWISE

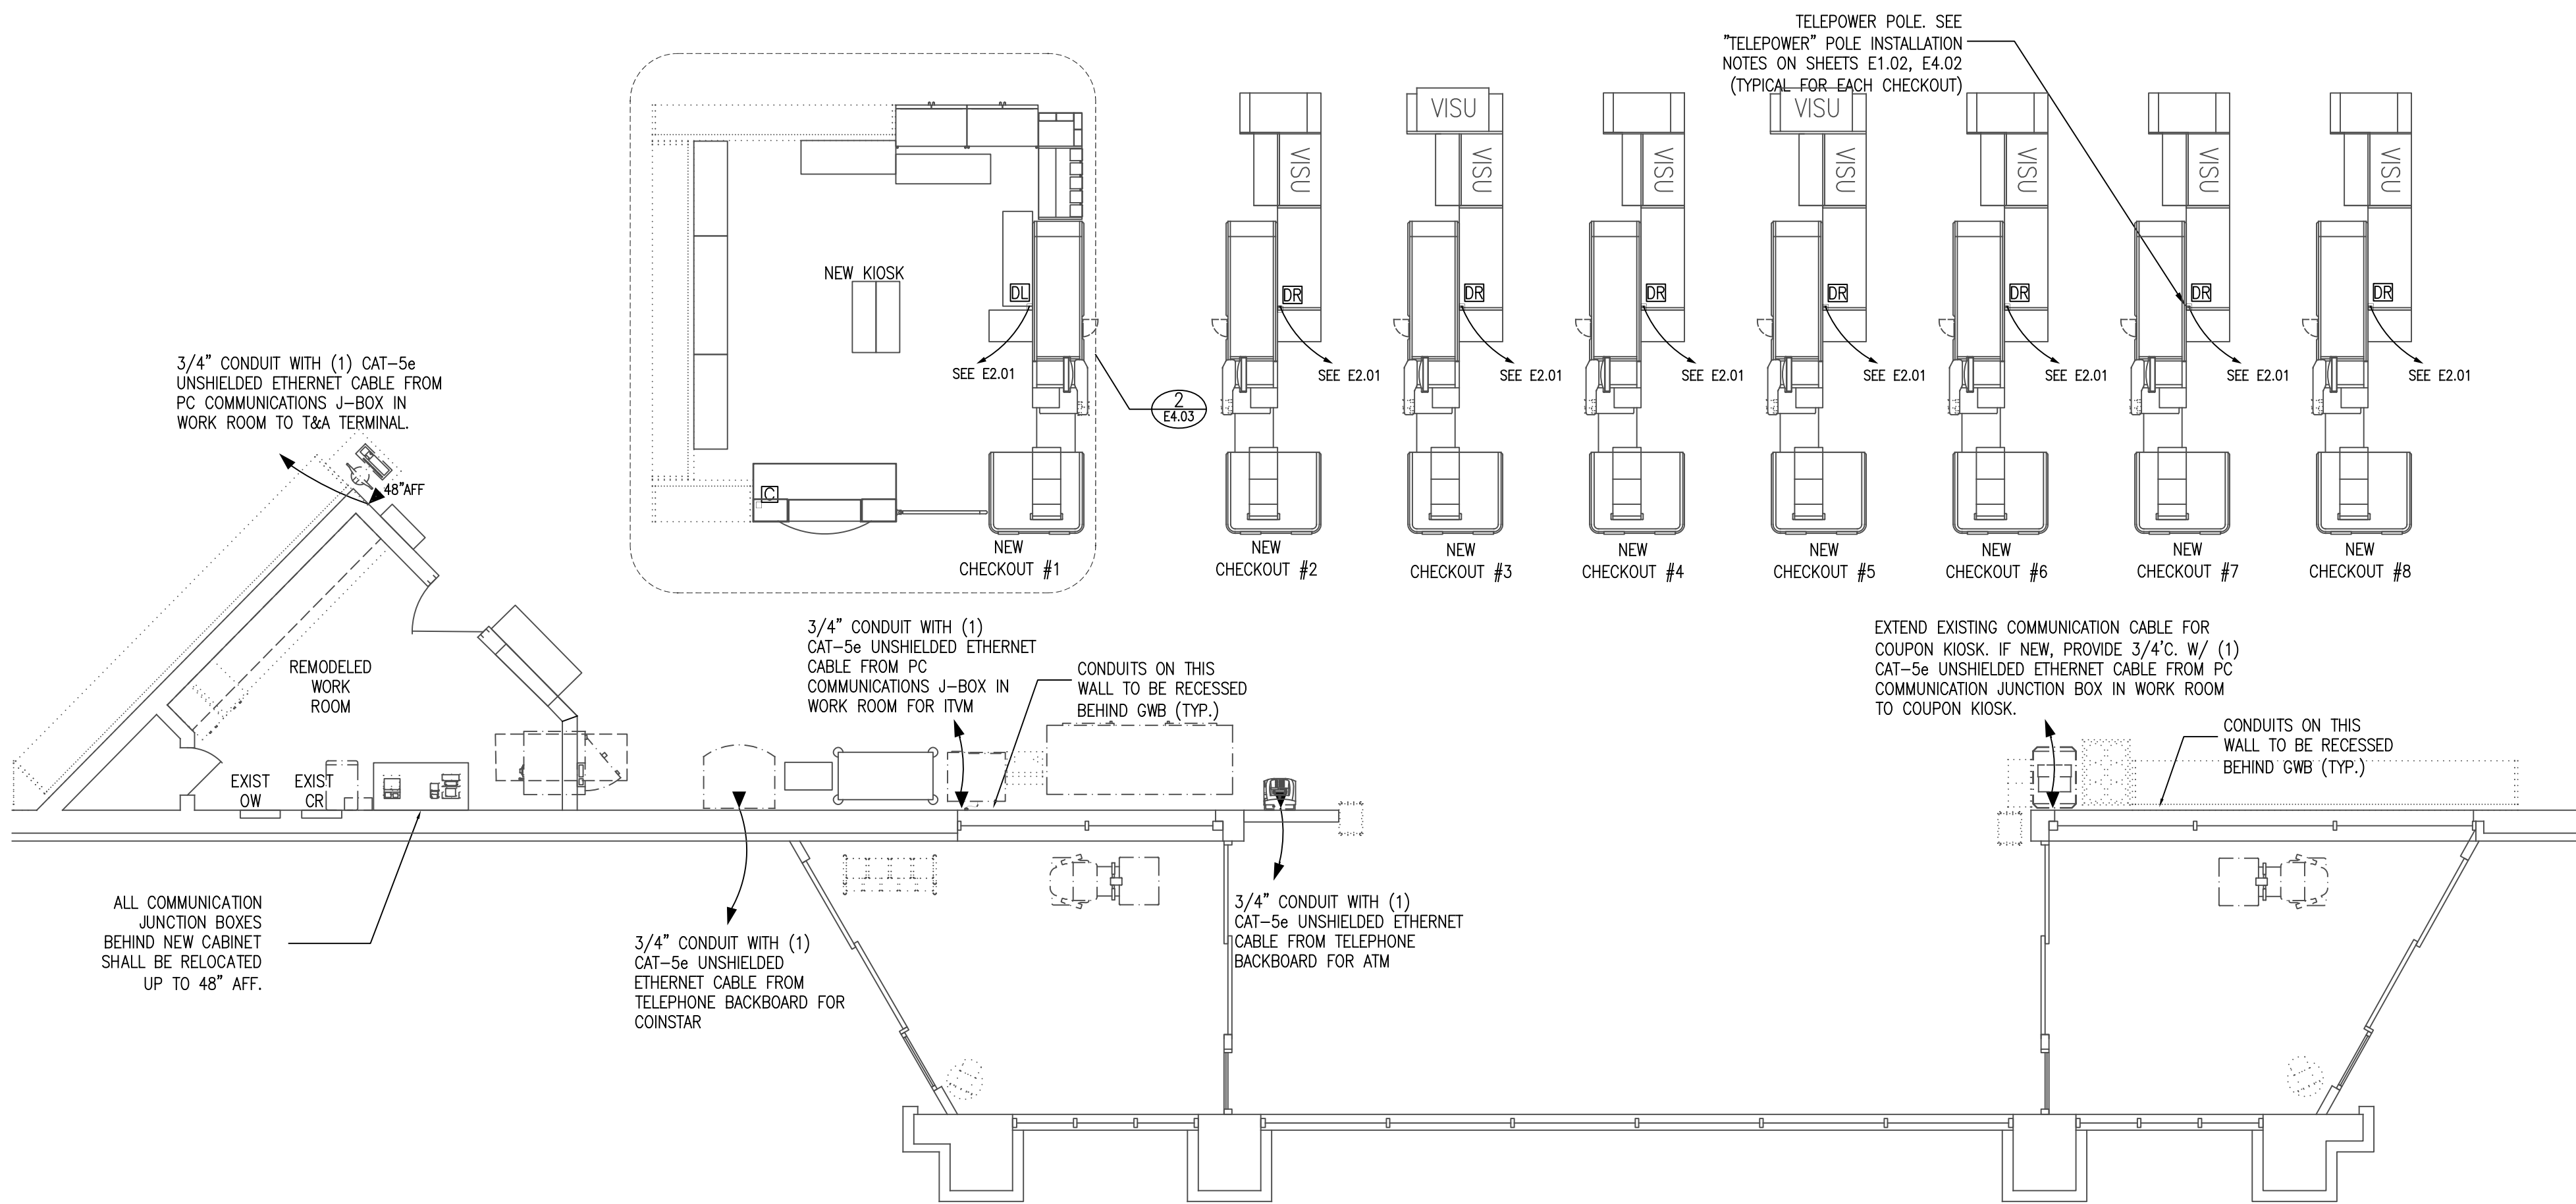

**1 ENLARGED COMMUNICATION WIRING PLAN**  
E4.03 SCALE: 3/16" = 1'-0"