


REVISIONS		
NO.	DESCRIPTION	DATE




ELECTRICAL WIRING KEY NOTES (X)

1. VERIFY EXISTING CONDITIONS.
2. RECEPTACLE TO BE FED FROM DEDICATED CLEAN POWER CIRCUIT. RE-FEED CIRCUIT AS NECESSARY TO MEET CONSTRUCTION REQUIREMENTS.
3. RE-CIRCUIT FROM CLEAN POWER TO "DIRTY" POWER.

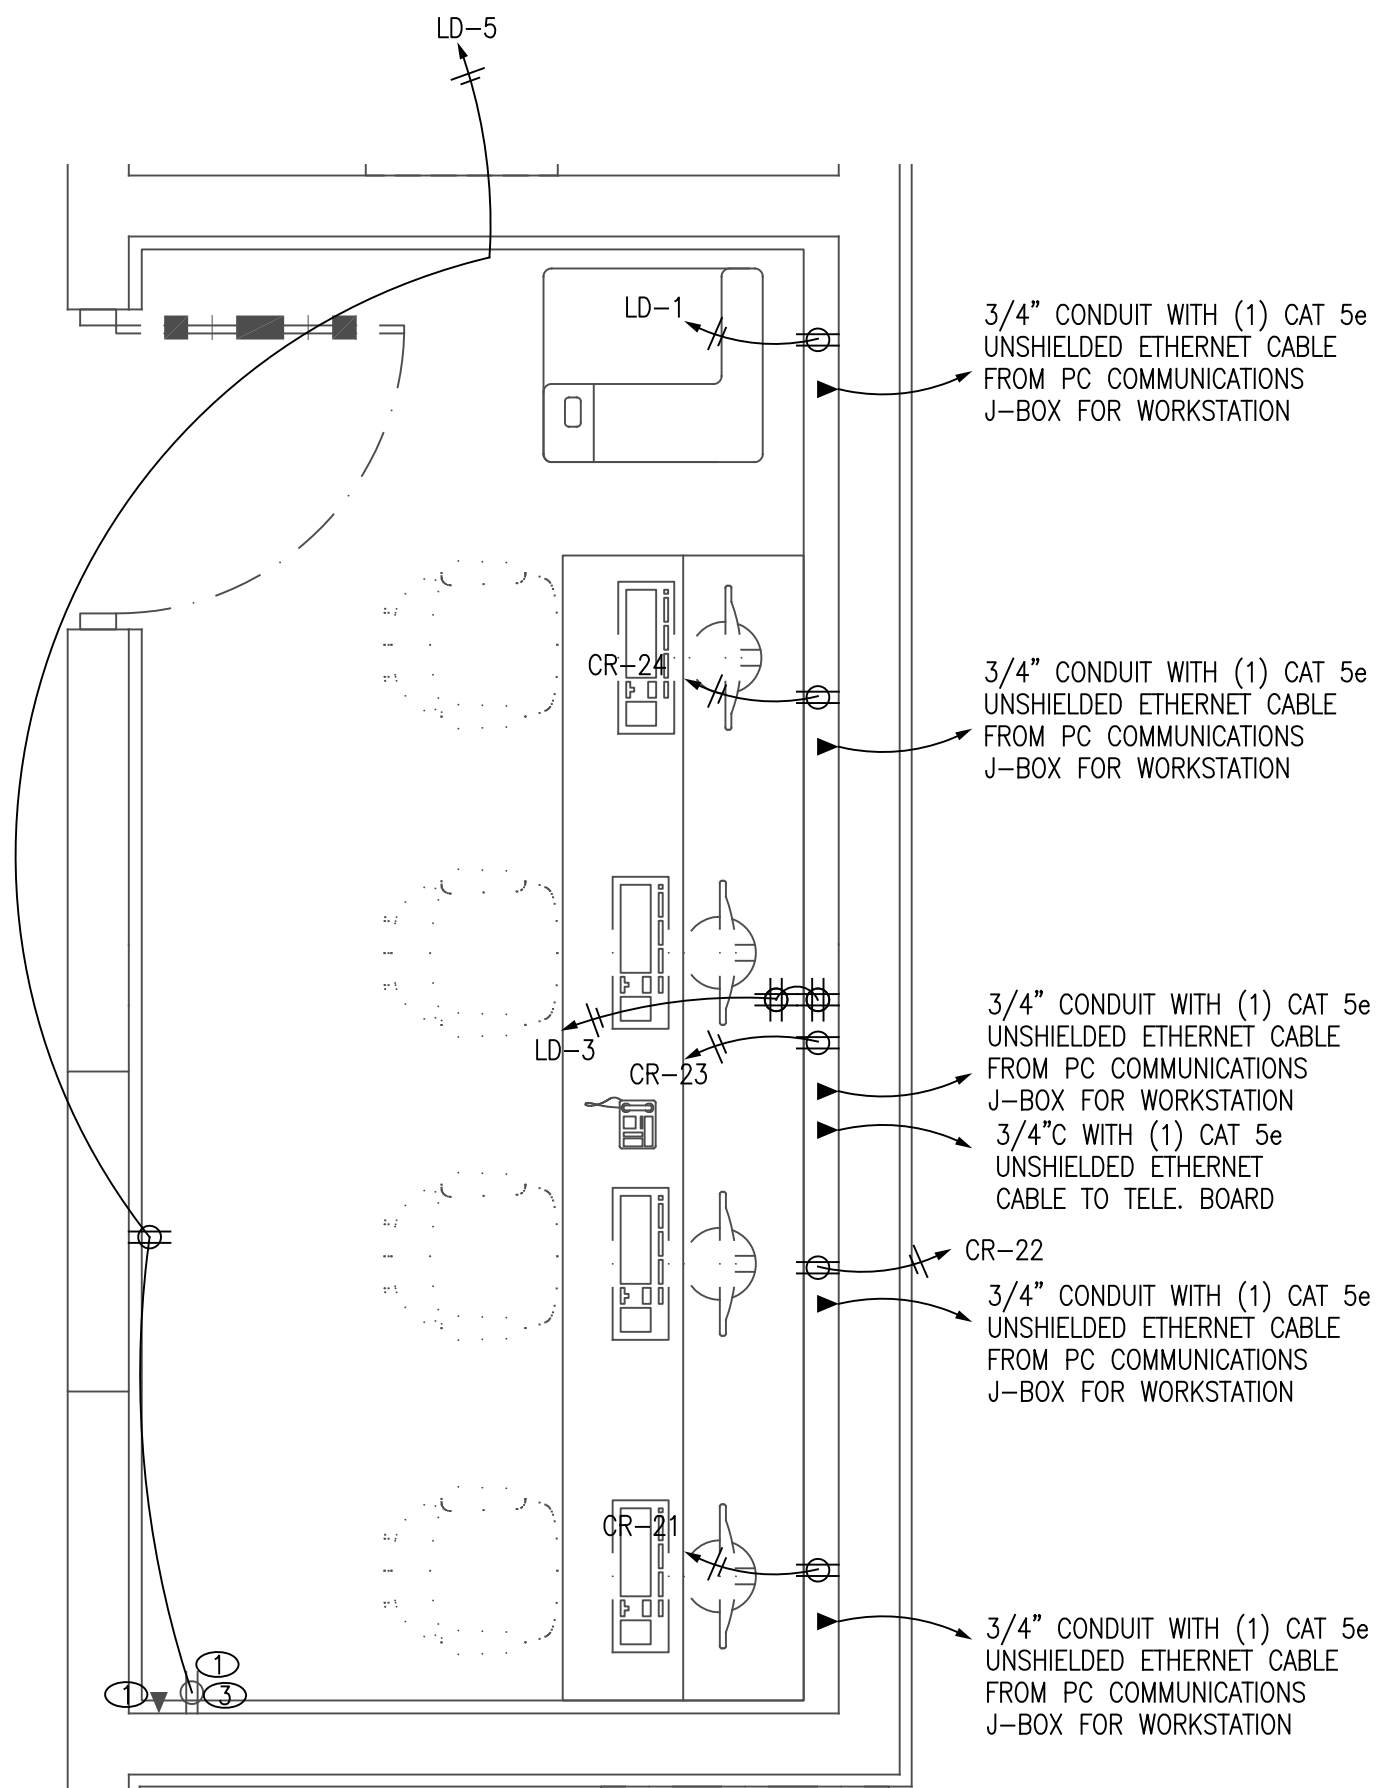

1 ENLARGED STORE/DEPT. MANAGER POWER PLAN
E4.04 SCALE : 1/2" = 1'-0"

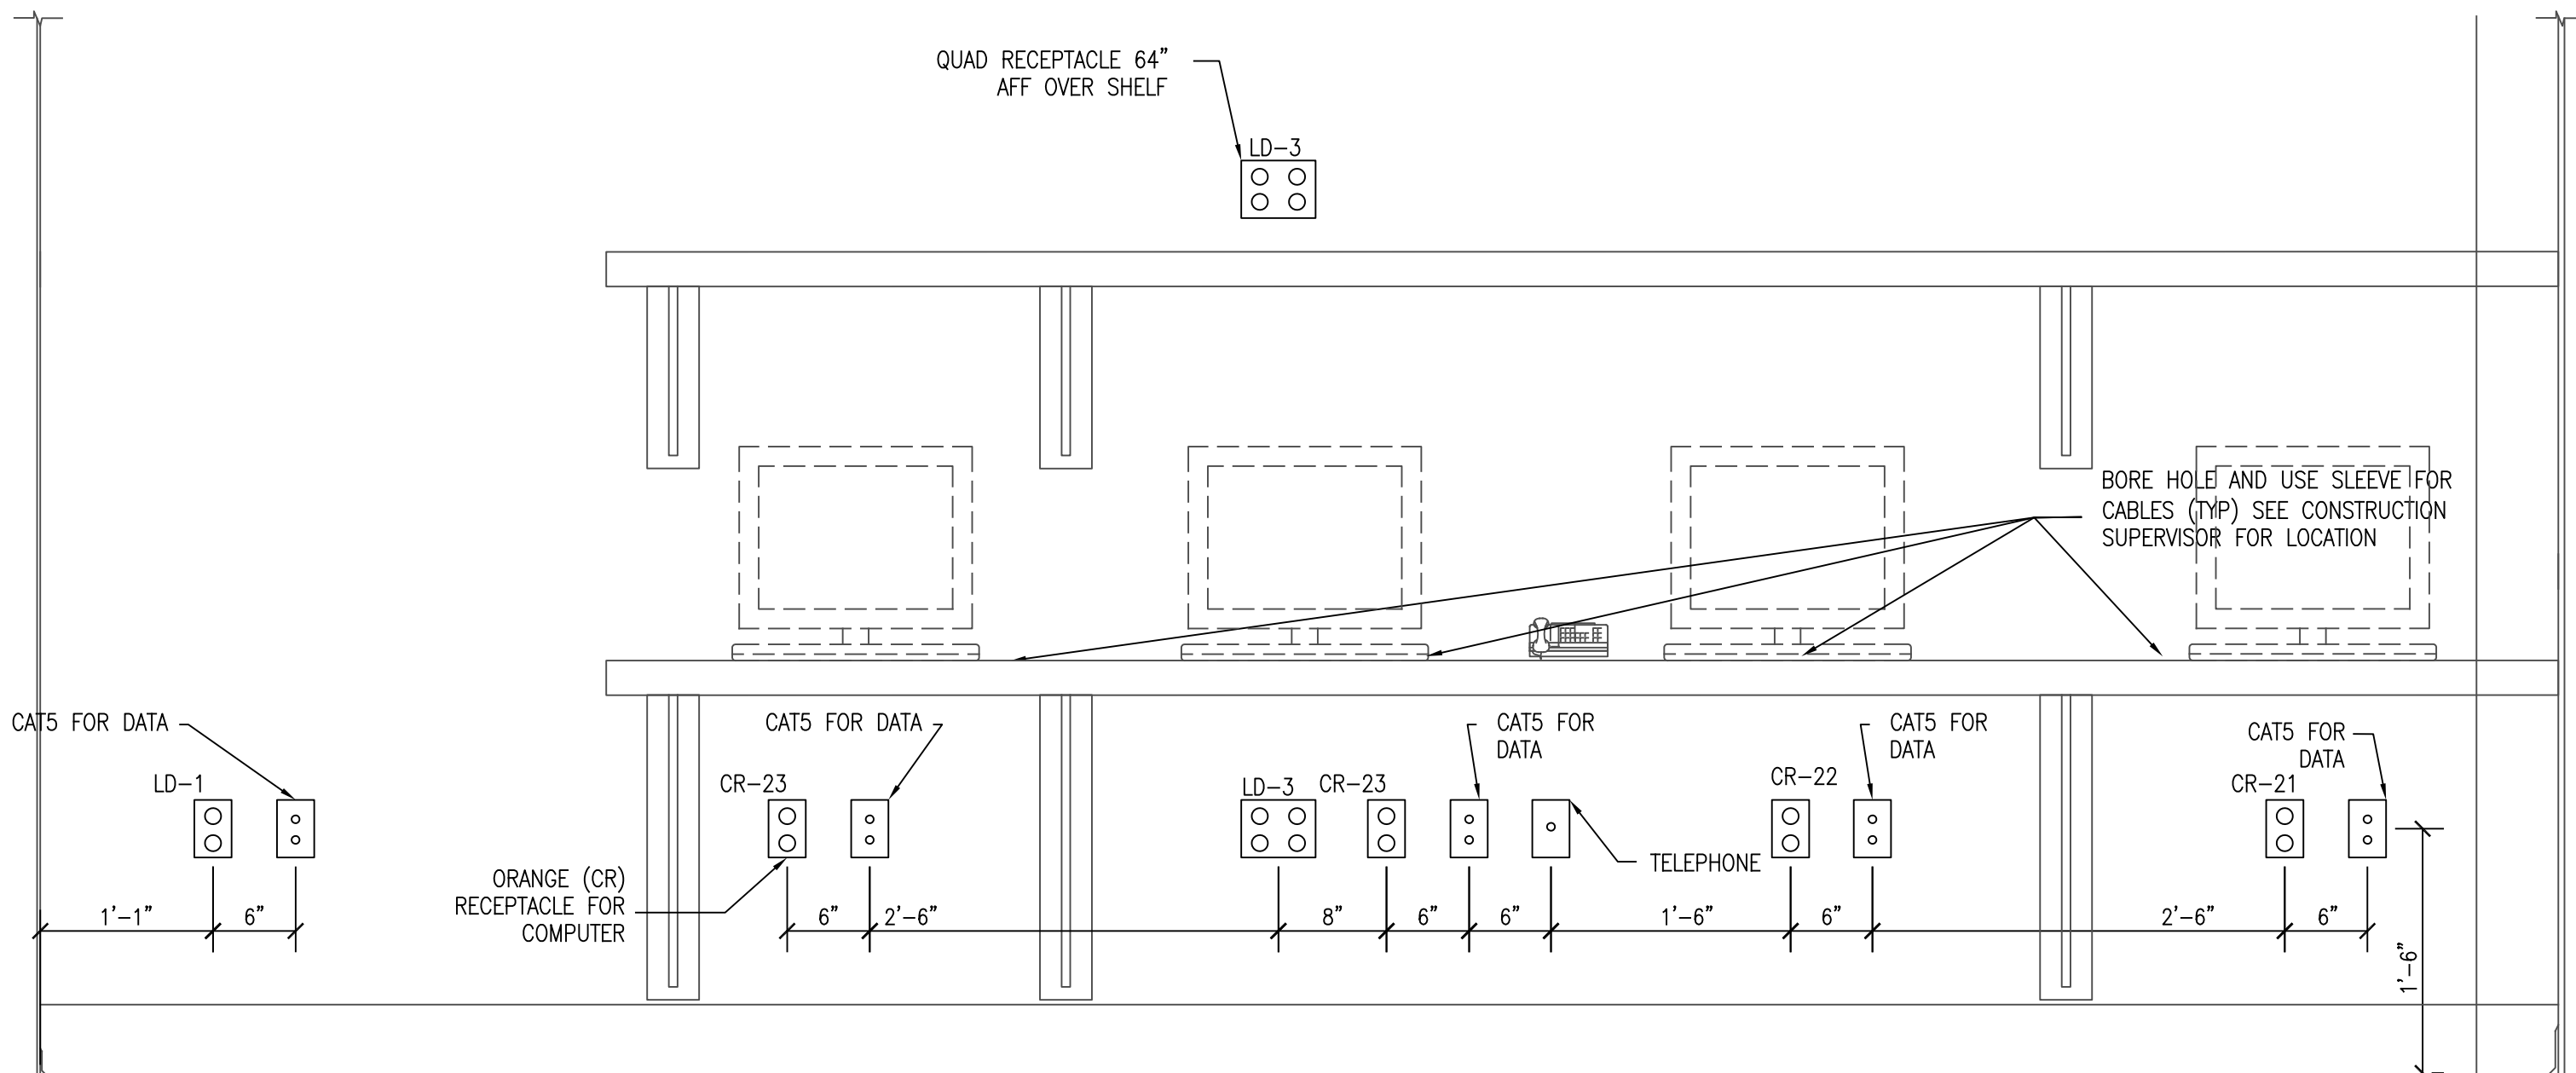

2 DEPARTMENT MANAGERS COUNTER ELEVATION
E4.04 SCALE : NONE